
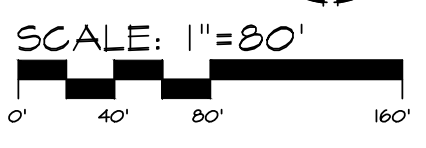


PL01.G:\MILENA-RODRIGUEZ.DWG Drawing:\MILENA-RODRIGUEZ.DWG 10/22/2011 5:16:49 PM CARL MCANAN, AUTOCAD PLOT (GENERAL DOCUMENTATION) AND EXPORT D (8.420 X 22.00 INCHES) SCALE: 1:1

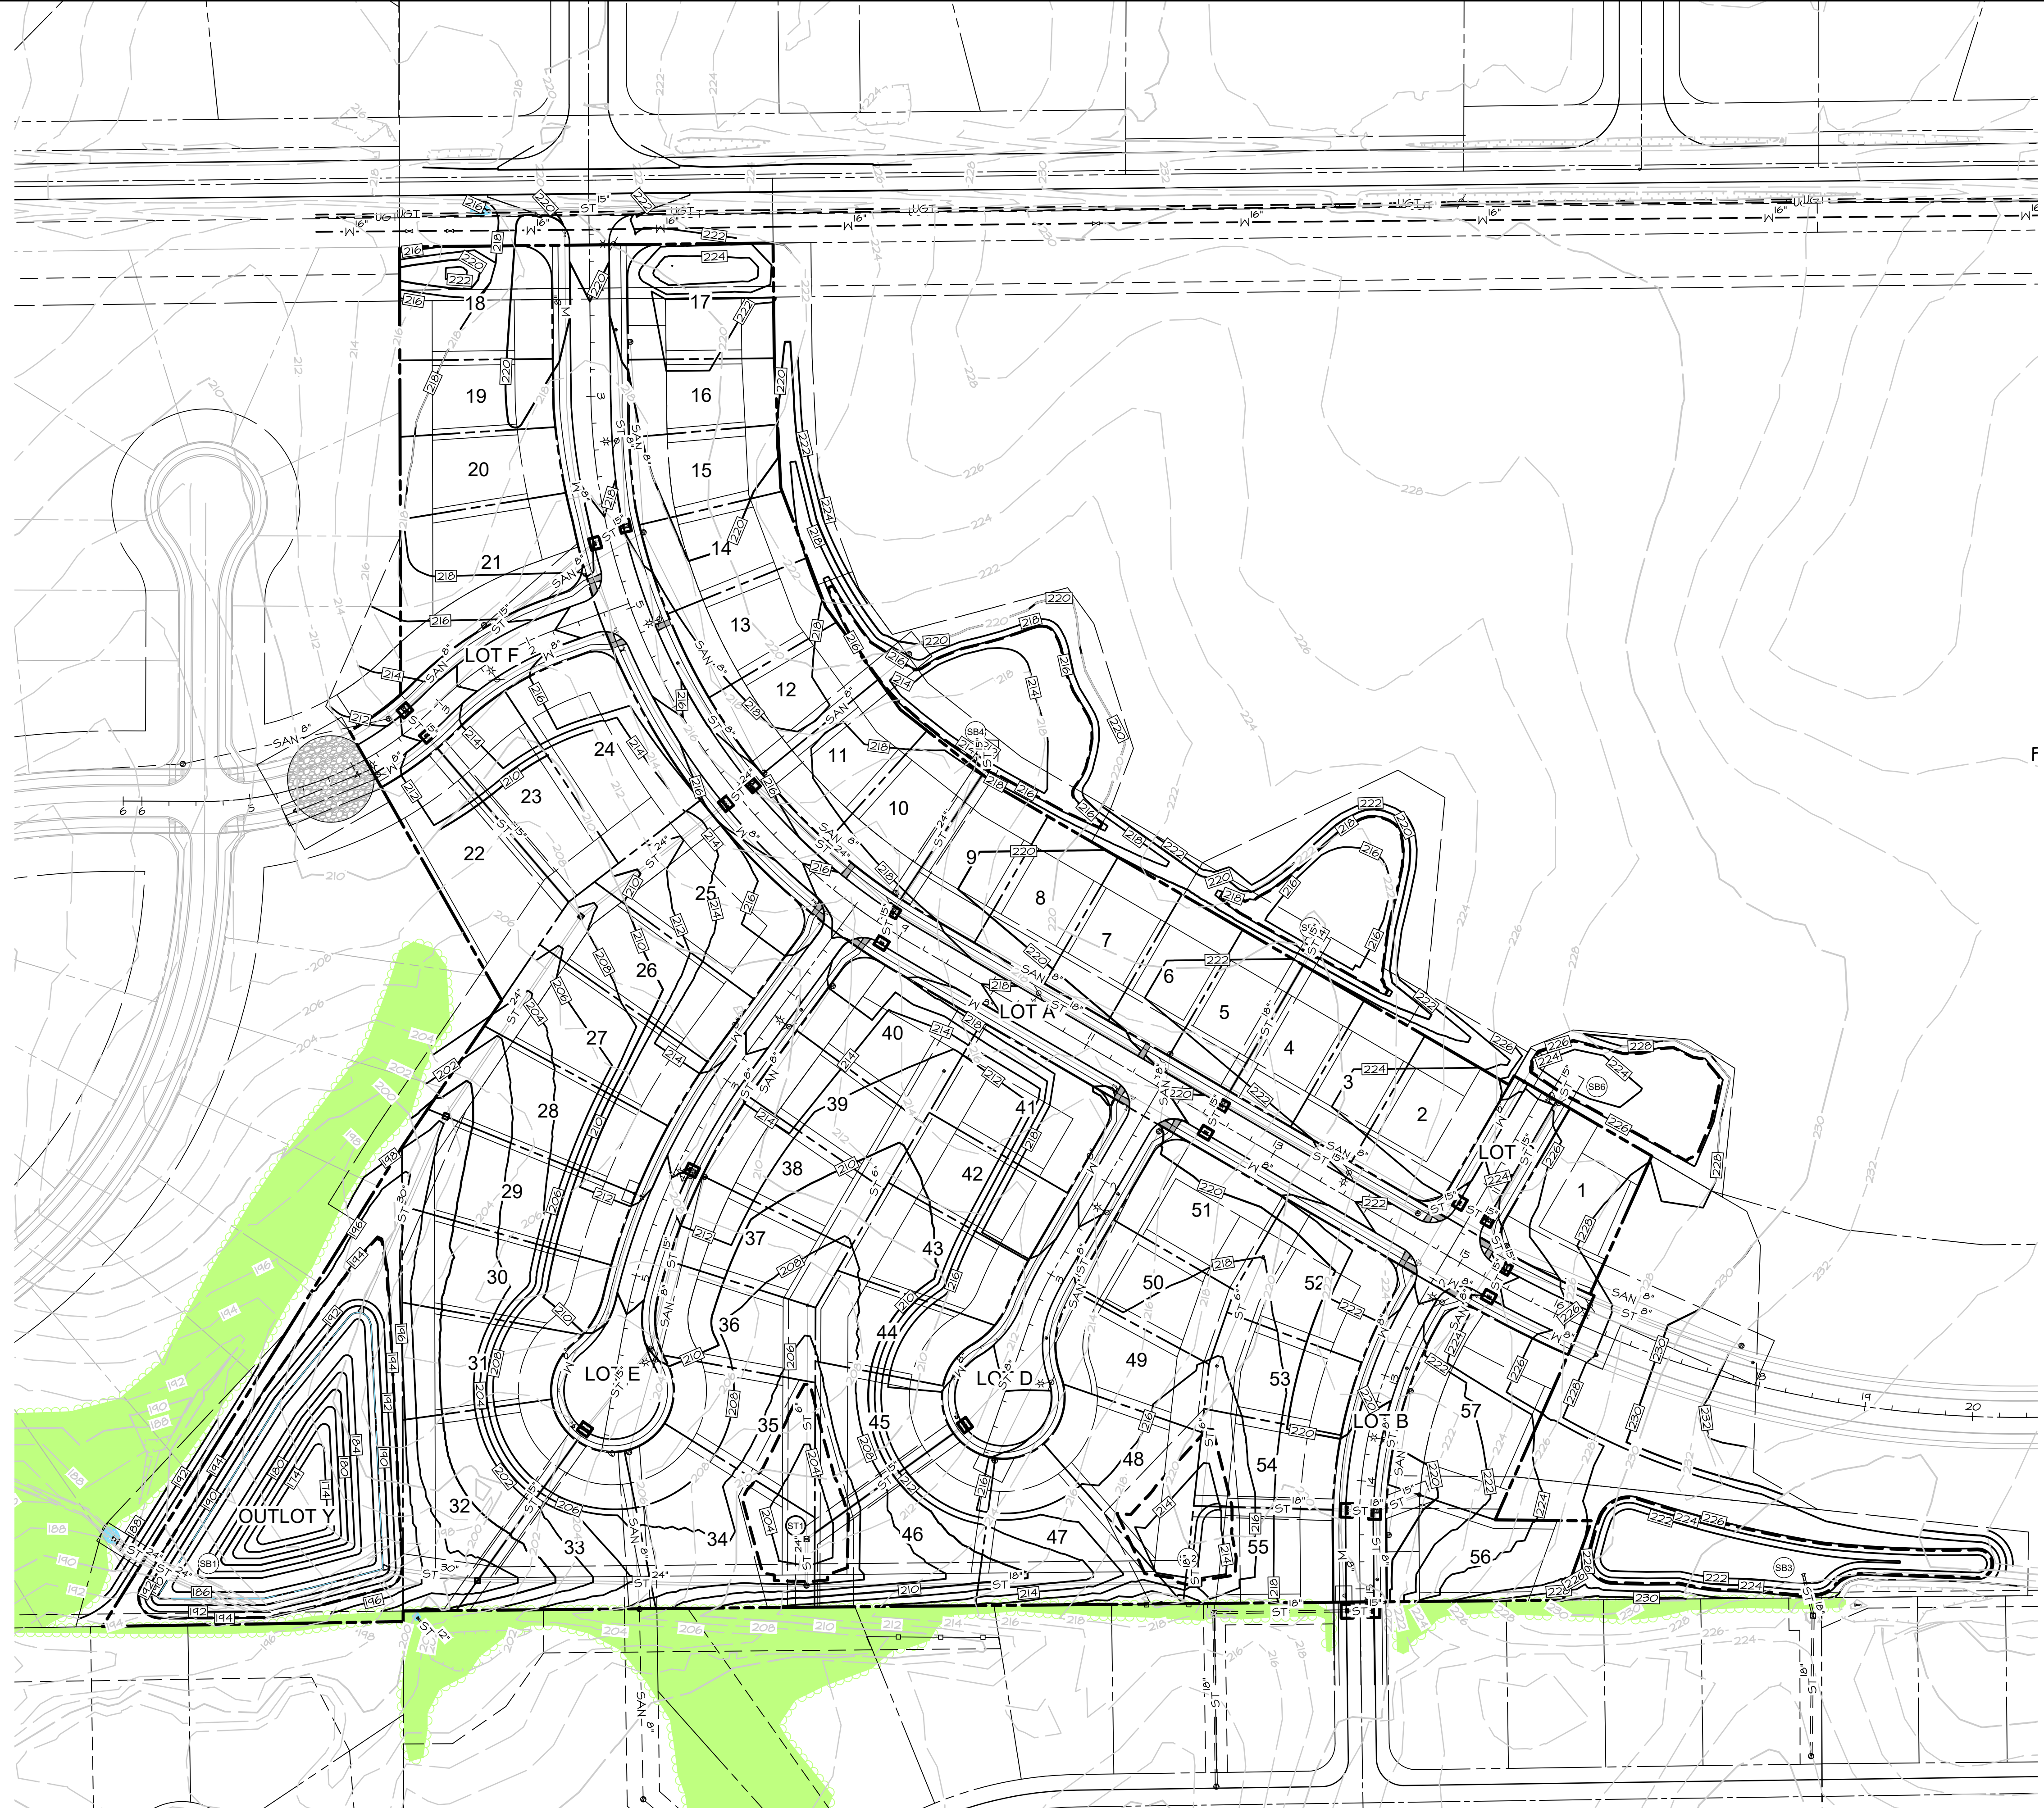

SCALE: 1"=20'

JORDAN LEA FLAT I
URBANDALE, IOWA

SHEET
3
A-1990

GRADING PLAN

DATE:	1s	REVISIONS	COMMENTS
	2s	1r	
	3s	2r	
	4s	3r	
	Field	4r	
	MPH	5r	
	CM	6r	

DATE OF SURVEY:
DESIGNED BY:
DRAWN BY:

Civil Engineering Consultants, Inc.
2400 86th Street Unit 12 Des Moines, Iowa 50322
515.276.4884 Fax: 515.276.7084 mail@cecinc.com

